
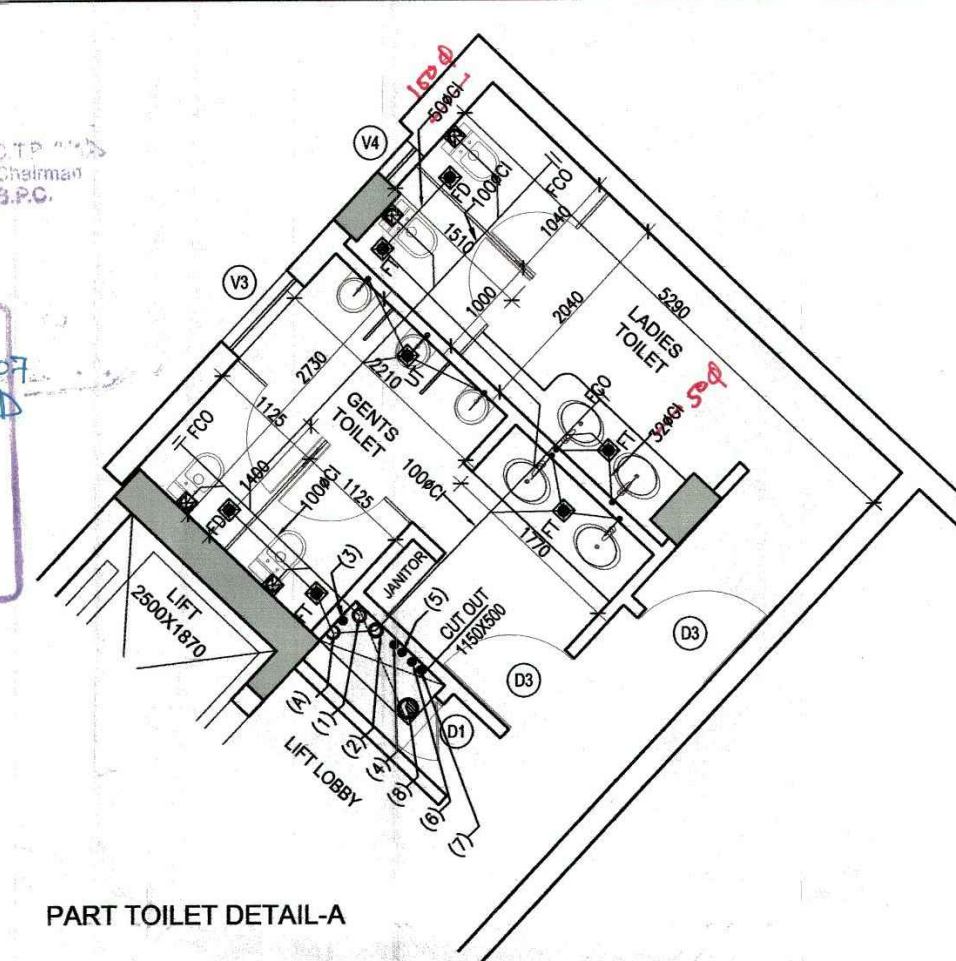


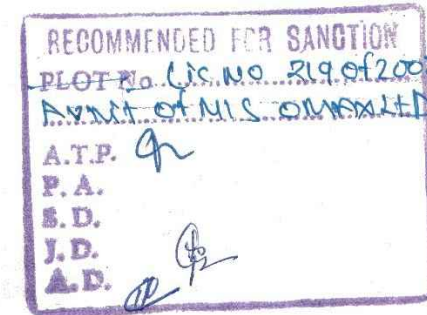

FIRE DETECTION LEGEND :-		
S.NO	SYMBOL	DESCRIPTION
1		MANUAL CALL POINT
2		FIRE FIGHTER PHONE JACK
3		FIRE SOUNDER
4		DIRECTION SOUNDER
5		SMOKE DETECTOR ON TRUE CEILING
6		SMOKE DETECTOR ABOVE FALSE CEILING
7		HEAT DETECTOR
8		LASER DETECTOR
9		RESPONSE INDICATOR

NOTES:-

1. ALL BUILDING EXCLUDING BASEMENTS FULLY AIR CONDITIONED AS PER N.B.C. NORMS.
2. ALL BASEMENTS ARE MECHANICALLY LIGHTED AND VENTILATED AS PER N.B.C. NORMS.
3. ALL BUILDING INCLUDING BASEMENT FULLY SPRINKLERED AS PER N.B.C. NORMS.

DOORS-WINDOWS SCHEDULE

TYPE	SIZE	C. LEVEL	L. LEVEL	REMARKS
D1	600 X 1600	+2000	+2100	
D2	900 X 2100	+2000	+2100	
D3	1200 X 2100	+2000	+2100	TOILET OFFICE ENT.
Wg	900 X 2250	+900	+3150	
V3	600 X 600	+2250	+2850	
V4	600 X 600	+2250	+2850	
GL	2975 X 2250	+900	+3150	
GLA	2100 X 2250	+900	+3150	
W5	3500 X 2250	+900	+3150	
W4	1000 X 1200	+900	+2100	
FD2	1500 X 2100	+000	+2100	SMOKE
CW1	GLASS CURTAIN WALL	AS /	ELEVATION	
CW2	GLASS CURTAIN WALL	AS /	ELEVATION	
CW3	GLASS CURTAIN WALL	AS /	ELEVATION	
CW4	GLASS CURTAIN WALL	AS /	ELEVATION	
CW5	GLASS CURTAIN WALL	AS /	ELEVATION	
CW6	33250 X 2250	+900	+3150	
CW7	33450 X 2250	+900	+3150	
CW8	33750 X 2250	+900	+3150	
CW9	34145 X 2250	+900	+3150	
CW10	34645 X 2250	+900	+3150	
CW11	35245 X 2250	+900	+3150	
CW13	14075 X 2250	+900	+3150	
CW14	14040 X 2250	+900	+3150	
CW15	14110 X 2250	+900	+3150	
CW16	14040 X 2250	+900	+3150	
CW17	14275 X 2250	+900	+3150	
CW18	14200 X 2250	+900	+3150	
CW19	14555 X 2250	+900	+3150	
CW20	14485 X 2250	+900	+3150	
CW21	14955 X 2250	+900	+3150	
CW22	14885 X 2250	+900	+3150	
CW23	15480 X 2250	+900	+3150	
CW24	15395 X 2250	+900	+3150	
CW25	16130 X 2250	+900	+3150	
CW26	16060 X 2250	+900	+3150	

 
FIRE FIGHTING LEGEND	
(A)	150# SPRINKLER PIPE FOR UPPER FLOOR
(B)	150# MS HYDRANT PIPE
(C)	80# DRAIN PIPE
FHC	FIRE HOSE CABINATE
	UPRIGHT TYPE SPRINKLER
	SIDE WALL SPRINKLER
	9 LITRES CAP. WATER CO2 TYPE FIRE EXTINGUISHERS
	4.5 KG CO2 TYPE FIRE EXTINGUISHERS

LEGEND FOR PLUMBING	
①	100% CI SOIL & VENT PIPE Hc1
②	100% CI WASTE & VENT PIPE Hc1
③	75% CI AS PIPE Hc1
④	COLD WATER SUPPLY DN TAKE
⑤	FLUSHING WATER DN TAKE
⑥	COLD WATER SUPPLY RISER
⑦	FLUSHING WATER RISER
⑧	1600 uPVC RAIN WATER PIPE
F.D	FLOOR DRAIN
F.T	FLOOR TRAP
U.T	URINAL TRAP
C.O.F	CLEAN OUT PLUG
C.I	CAST IRON PIPE
G.I	GALVANIZED IRON PIPE
C.W.S	COLD WATER SUPPLY PIPE
H.W.S	HOT WATER SUPPLY PIPE
H.W.R	HOT WATER RETURN PIPE

rg. title	TYPICAL FLOOR PLAN (3RD, 4TH, 5TH & 7TH)
-----------	---

project	REVISED BUILDING PLAN OF COMMERCIAL COLONY MEASUR 2.851ACRES,(LICENCE NO. 219 C 2007 DATED 09-09-2007) IN SECTOR-47 GURGAON,BEING DEVELOPED BY M/S AUTOMAX (A UNIT OF M/S OMAX AUTOS LT
---------	---

architects	 sikka associates architects	architecture master planning urban design interior design project management
	A2/1, africa avenue safdarjung enclave, new delhi-110029 tel+91-11343-46104/48104 fax+91-11343-46104/48104	

ARCHITECT	OWNER
 raman sikka REGN. No. 03/16497	

drg. no	SB/A-04	scale: 1:100	S.NO.	
		date: MAY, 2015		