



SIXTH FLOOR PLAN

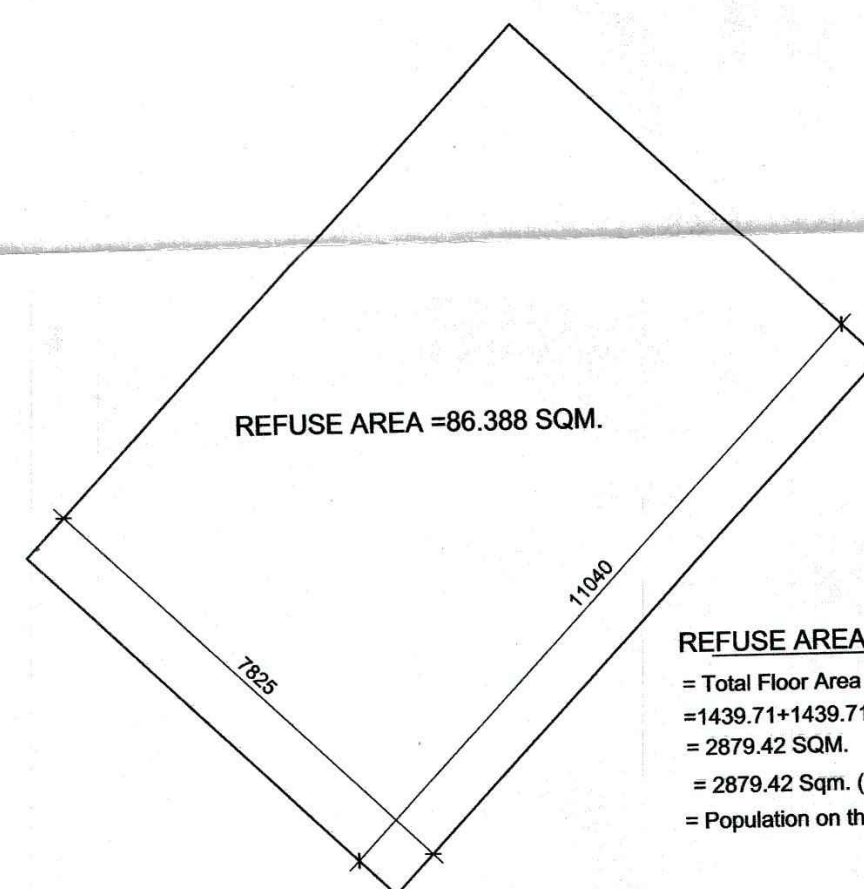

REFUSE AREA CALCULATION
 = Total Floor Area (5th + 7th Floor)
 = 1439.71 + 1439.71
 = 2879.42 SQM.
 = 2879.42 Sqm. (FAR of two floor)
 = Population on three floor = @10sqm/person
 = 287.942 person
 Say = 288 person
 = Refuse area required = 288 X 0.3 Say/person
 = 86.382 Sqm.
 = Refuse area provided = 86.388 Sqm.

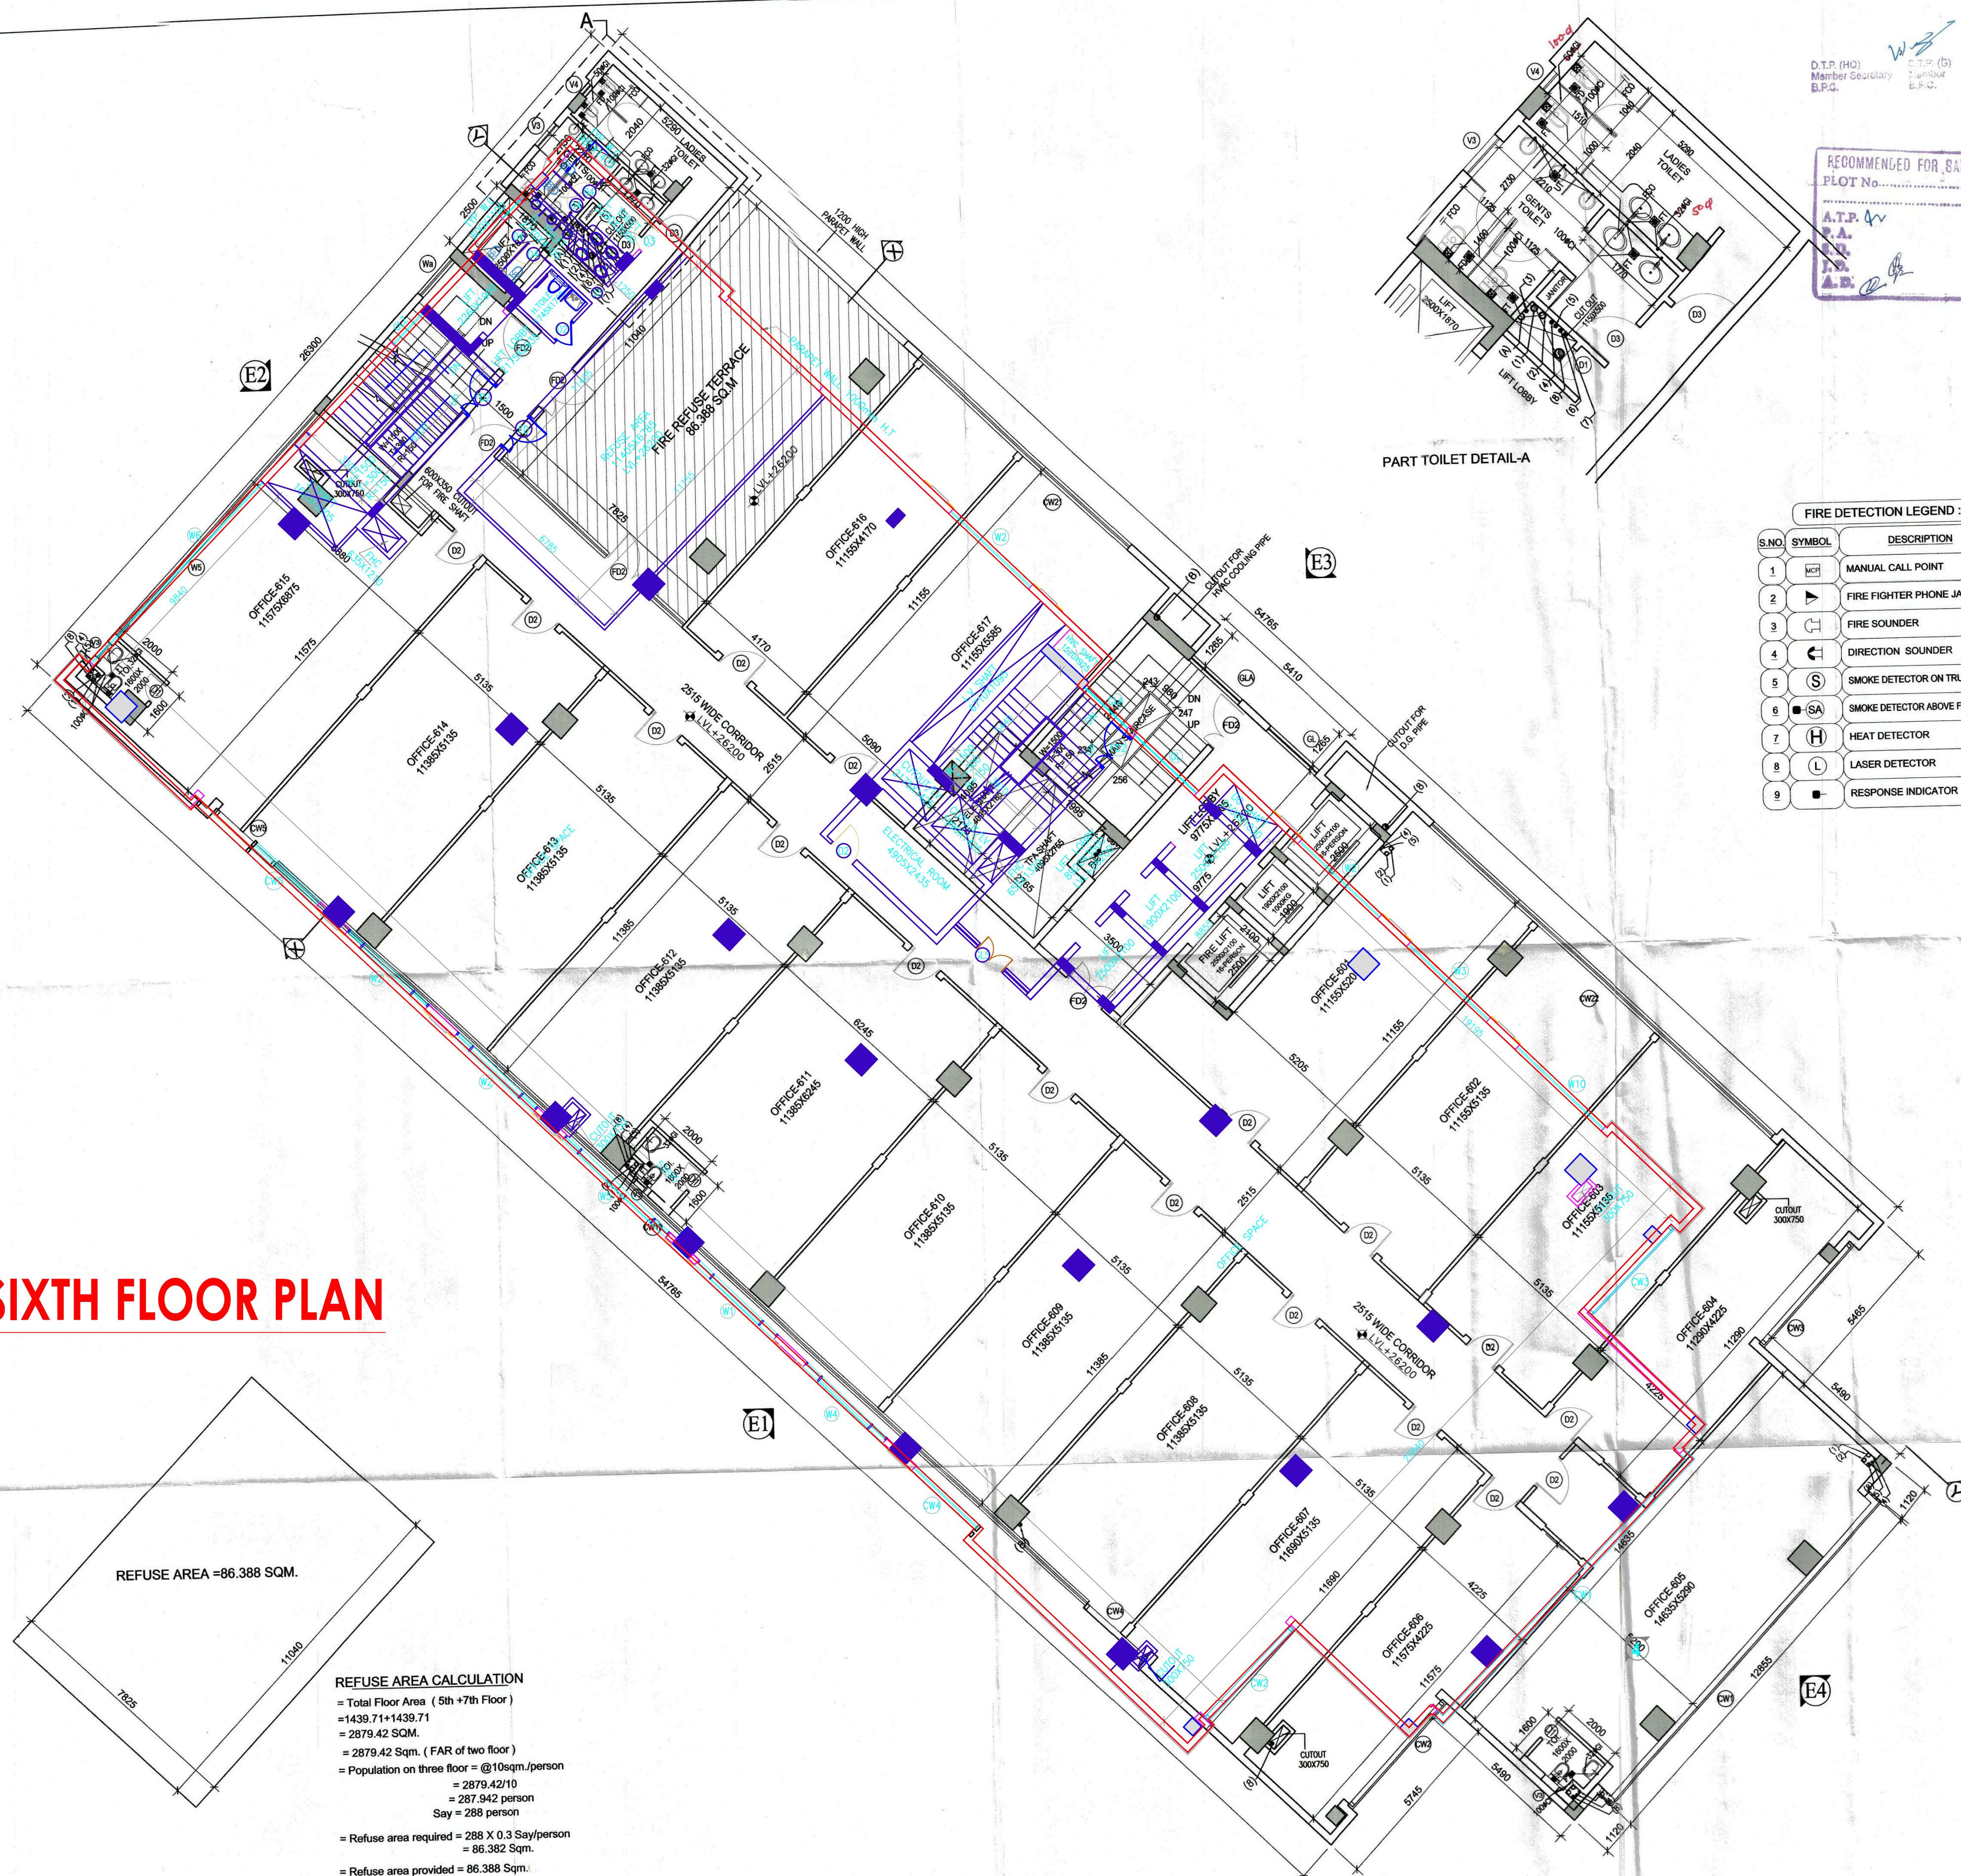

RECOMMENDED FOR SANCTION
 PLOT No. 47
 A.T.P. 47
 S.A.
 R.S.
 A.B.

FIRE DETECTION LEGEND :-

S.NO.	SYMBOL	DESCRIPTION
1	[Symbol]	MANUAL CALL POINT
2	[Symbol]	FIRE FIGHTER PHONE JACK
3	[Symbol]	FIRE SOUNDER
4	[Symbol]	DIRECTION SOUNDER
5	[Symbol]	SMOKE DETECTOR ON TRUE CEILING
6	[Symbol]	SMOKE DETECTOR ABOVE FALSE CEILING
7	[Symbol]	HEAT DETECTOR
8	[Symbol]	LASER DETECTOR
9	[Symbol]	RESPONSE INDICATOR

NOTES:-
 1. ALL BUILDING EXCLUDING BASEMENTS FULLY AIR CONDITIONED AS PER N.B.C. NORMS.
 2. ALL BASEMENTS ARE MECHANICALLY LIGHTED AND VENTILATED AS PER N.B.C. NORMS.
 3. ALL BUILDING INCLUDING BASEMENT FULLY SPRINKLERED AS PER N.B.C. NORMS.

DOORS-WINDOWS SCHEDULE

TYPE	SIZE	C. LVL	L. LVL	REMARKS
D1	600 X 1600	+500	+2100	SHAFT DOOR
D3	900 X 2100	+000	+2100	TOILET
D2	1200 X 2100	+000	+2100	OFFICE ENT.
W6	1500 X 2250	+900	+3150	
V3	900 X 600	+2250	+2850	
V4	400 X 600	+2250	+2850	
CL	2975 X 2250	+900	+3150	
GJA	2100 X 2250	+900	+3150	
W5	3500 X 2250	+900	+3150	
W4	1000 X 1200	+900	+2100	
FD2	1500 X 2100	+000	+2100	SMOKE
CW1	GLASS CURTAIN WALL	AS/ELEVATION		
CW2	GLASS CURTAIN WALL	AS/ELEVATION		
CW3	GLASS CURTAIN WALL	AS/ELEVATION		
CW4	GLASS CURTAIN WALL	AS/ELEVATION		
CW5	GLASS CURTAIN WALL	AS/ELEVATION		
CW6	33250 X 2250	+900	+3150	
CW7	33450 X 2250	+900	+3150	
CW8	33750 X 2250	+900	+3150	
CW9	34145 X 2250	+900	+3150	
CW10	34645 X 2250	+900	+3150	
CW11	35245 X 2250	+900	+3150	
CW13	14075 X 2250	+900	+3150	
CW14	14040 X 2250	+900	+3150	
CW15	14110 X 2250	+900	+3150	
CW16	14040 X 2250	+900	+3150	
CW17	14275 X 2250	+900	+3150	
CW18	14200 X 2250	+900	+3150	
CW19	14555 X 2250	+900	+3150	
CW20	14485 X 2250	+900	+3150	
CW21	14955 X 2250	+900	+3150	
CW22	14885 X 2250	+900	+3150	
CW23	15480 X 2250	+900	+3150	
CW24	15395 X 2250	+900	+3150	
CW25	16130 X 2250	+900	+3150	
CW26	16060 X 2250	+900	+3150	

FIRE FIGHTING LEGEND

(A)	150# SPRINKLER PIPE FOR UPPER FLOOR
(B)	150# MS HYDRANT PIPE
(C)	80# DRAIN PIPE
FHC	FIRE HOSE CABINATE
*	UPRIGHT TYPE SPRINKLER
SW	SIDE WALL SPRINKLER
8L	8 LITRES CAP. WATER CO2 TYPE FIRE EXTINGUISHERS
4.5K	4.5 Kg CO2 TYPE FIRE EXTINGUISHERS

LEGEND FOR PLUMBING

100# CI	SOIL & VENT PIPE H.C.I.
100# CI	WASTE & VENT PIPE H.C.I.
75# CI	AS PIPE H.C.I.
4	COLD WATER SUPPLY DN TAKE
5	FLUSHING WATER DN TAKE
6	COLD WATER SUPPLY RISER
7	FLUSHING WATER RISER
8	100# UPVC RAIN WATER PIPE
F.D	FLOOR DRAIN
F.T	FLOOR TRAP
U.T	URINAL TRAP
C.O.B	CLEAN OUT PLUG
C.I	CAST IRON PIPE
G.I	GALVANIZED IRON PIPE
C.W.S	COLD WATER SUPPLY PIPE
H.W.S	HOT WATER SUPPLY PIPE
H.W.R	HOT WATER RETURN PIPE

SIXTH FLOOR PLAN

REVISED BUILDING PLAN OF
 COMMERCIAL COLONY MEASURING
 2.851ACRES. (LICENCE NO. 219 OF
 2007 DATED 09-09-2007) IN
 SECTOR-47 GURGAON, BEING
 DEVELOPED BY M/S AUTOMAX
 (A UNIT OF M/S OMAX AUTOS LTD.)

ARCHITECTS
 SAA
 sika associates architects
 A2/1, office avenue solarising metro, new delhi-110029 tel: (+91-11) 43232325
 fax: 26194481, e-mail: saas@sikaassociates.net

ARCHITECT
 Raman Sikka
 REGN. No. 93/16497

OWNER
 M/S AUTOMAX

scale: 1:100
date: MAY, 2015

SB/A-05